



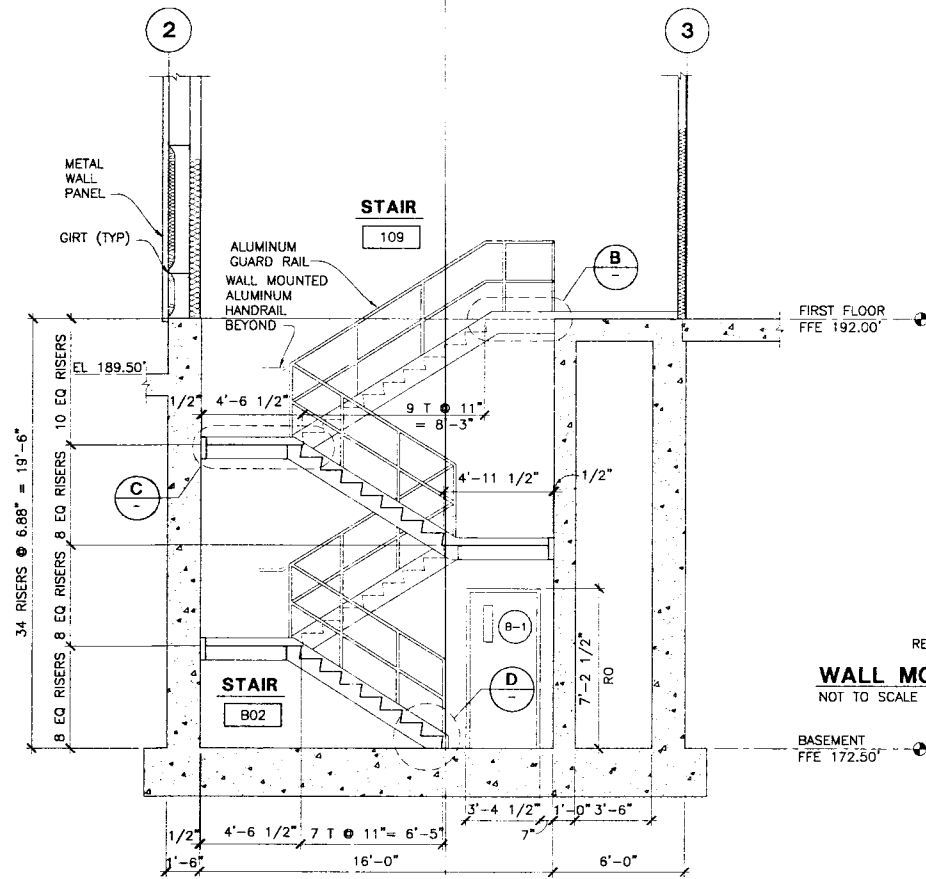


SECTION  **A-2, A-3**
SCALE: 1/4"=1'-0"

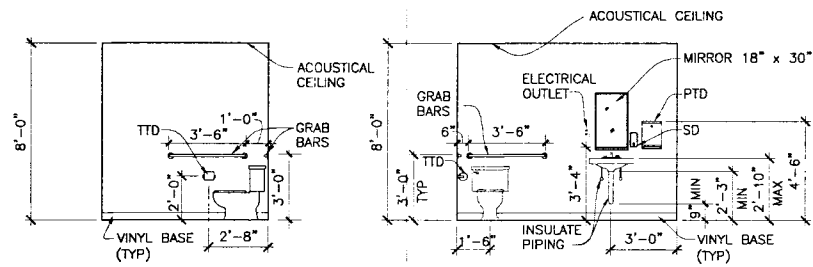


ELEVATION A
SCALE: 1/4"=1'-0"


ELEVATION B
SCALE: 1/4"=1'-0"

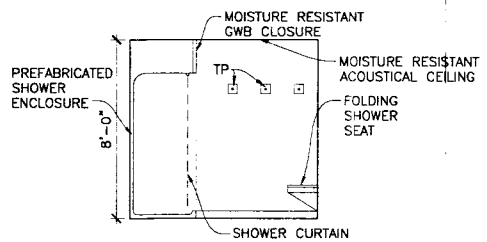


ELEVATION C
SCALE: 1/4"=1'-0"

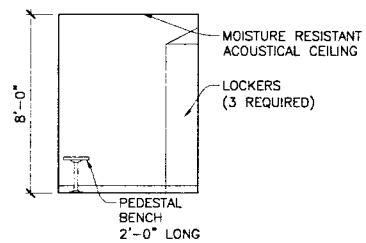

ELEVATION D
SCALE: 1/4"=1'-0"

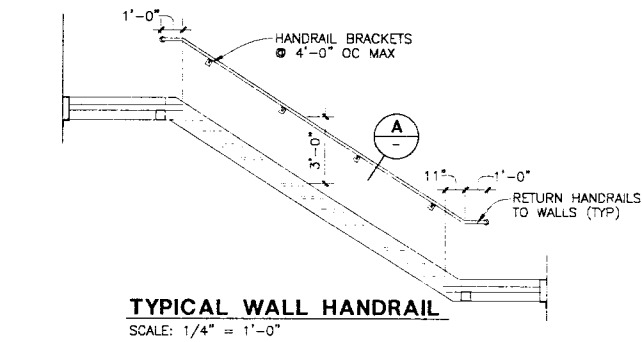


TYPICAL WALL HANDRAIL
SCALE: 1/4" = 1'-0"

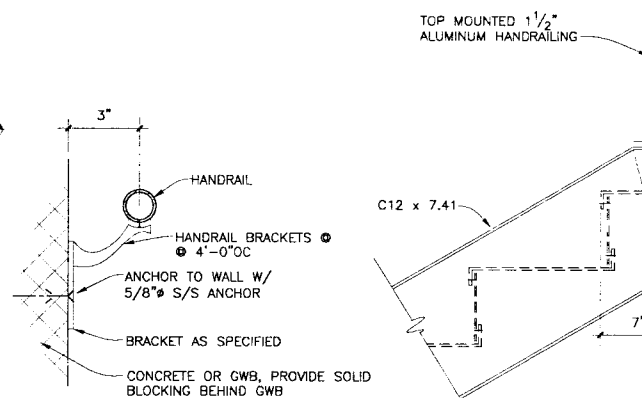


RETURN HANDRAIL ENDS TO THE WALL (TYP)

WALL MOUNTED HANDRAIL DETAIL

NOT TO SCALE

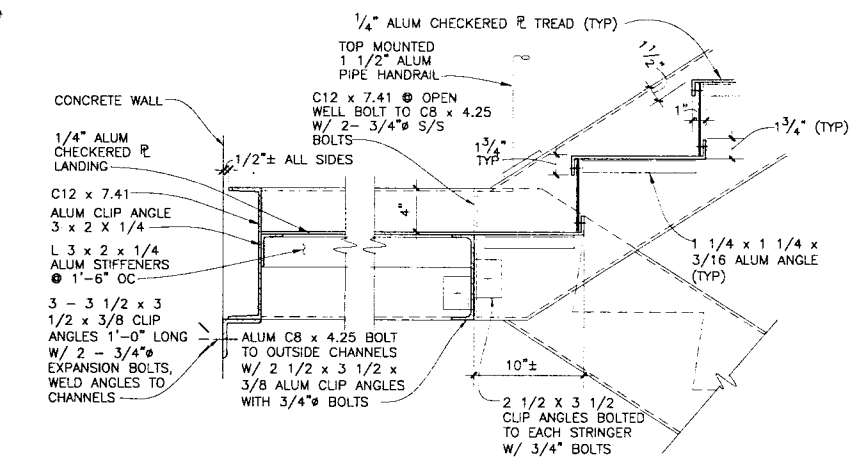




DETAIL C
SCALE: 1 1/2" = 1'-0"

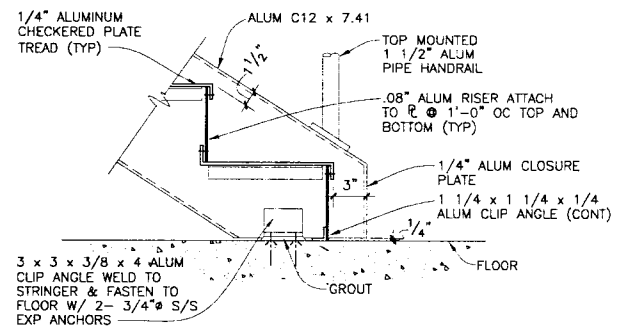

DETAIL D
SCALE: 1 1/2" = 1'-0"

STAIR NOTES:

  
1. ALL BOLTS AND FASTENERS SHALL BE STAINLESS STEEL.
2. ALL EXPANSION ANCHORS SHALL HAVE A MINIMUM EMBEDMENT OF 4 INCHES.
3. SECURE THE CHECKERED PLATE TO SUPPORTS W/ 3/8" SS COUNTERSUNK BOLTS @ 1'-0" OC @ LANDINGS AND 2 @ EACH END OF TREAD.
4. PREFABRICATE CAST ALUMINUM TREADS CAN BE USED IN PLACE OF THE CHECKERED PLATE TREADS.
5. REFER TO THE STRUCTURAL DRAWINGS FOR GENERAL NOTES AND TYPICAL DETAILS.

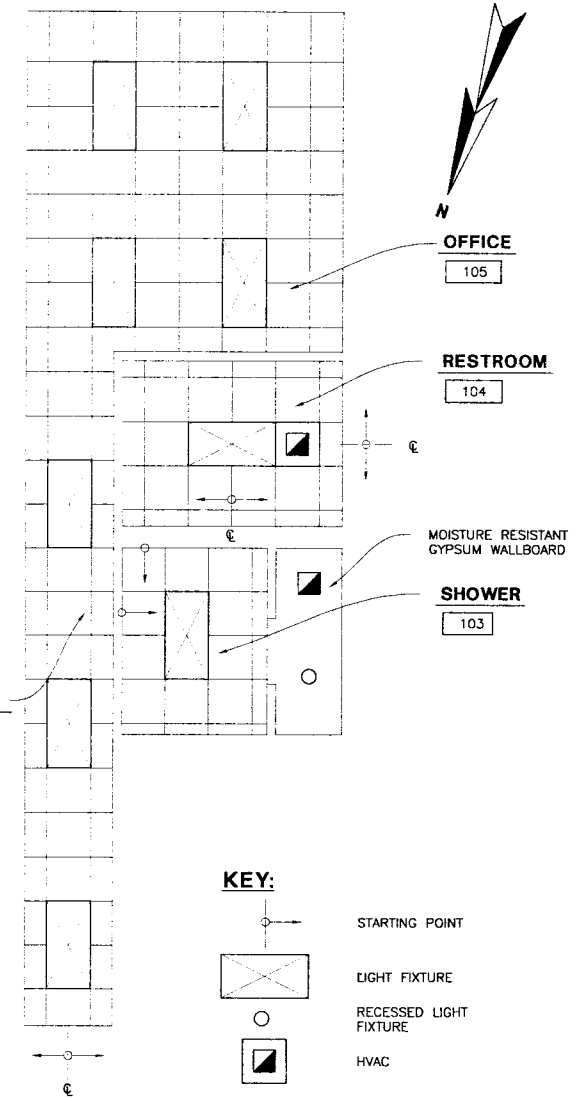

NOTE: 1. ALL ACOUSTICAL CEILINGS SHALL BE 8'-0" ABOVE FINISHED FLOOR UNLESS OTHERWISE NOTED.

REFLECTED CEILING PLAN
SCALE: 1/4"=1'-0"

 KEY:



STARTING POINT

LIGHT FIXTURE

RECESSED LIGHT
FIXTURE

HVAC

NOTES:

1. REFER TO DRAWING A-1 FOR ARCHITECTURAL NOTES.

NO	RECORD DRAWINGS 12/04	APR 11	DATE	INDEX/ST. PRINTS
△				ISSUED FOR REVIEW 12-02
△				ISSUED FOR BIDDING 2-03
△				DATE LOCATED
△				LAST REVISAL ON
0				REMARK

DRAWN BY CJB
CHECKED BY DIP/WJF
DATE 12-13-02
APPROVED BY WJF
DATE 12-20-02
BOOK NO. —
PROJECT NO. 7051K
SCALE AS NOTED

Wright-Pierce
169 Main Street 700 Plaza Middlesex
Middletown, Connecticut USA 08457
TEL (860) 343-8297 FAX (860) 343-9504

DEPARTMENT OF PUBLIC WORKS
TOWN OF EAST LONGMEADOW, MA
VINELAND AVENUE PUMP STATION
CONTRACTS NO. 1 AND NO. 2
STAIR SECTIONS AND DETAILS,
MISCELLANEOUS ELEVATIONS, DETAILS
AND REFLECTED CEILING PLAN

DWG A-5