


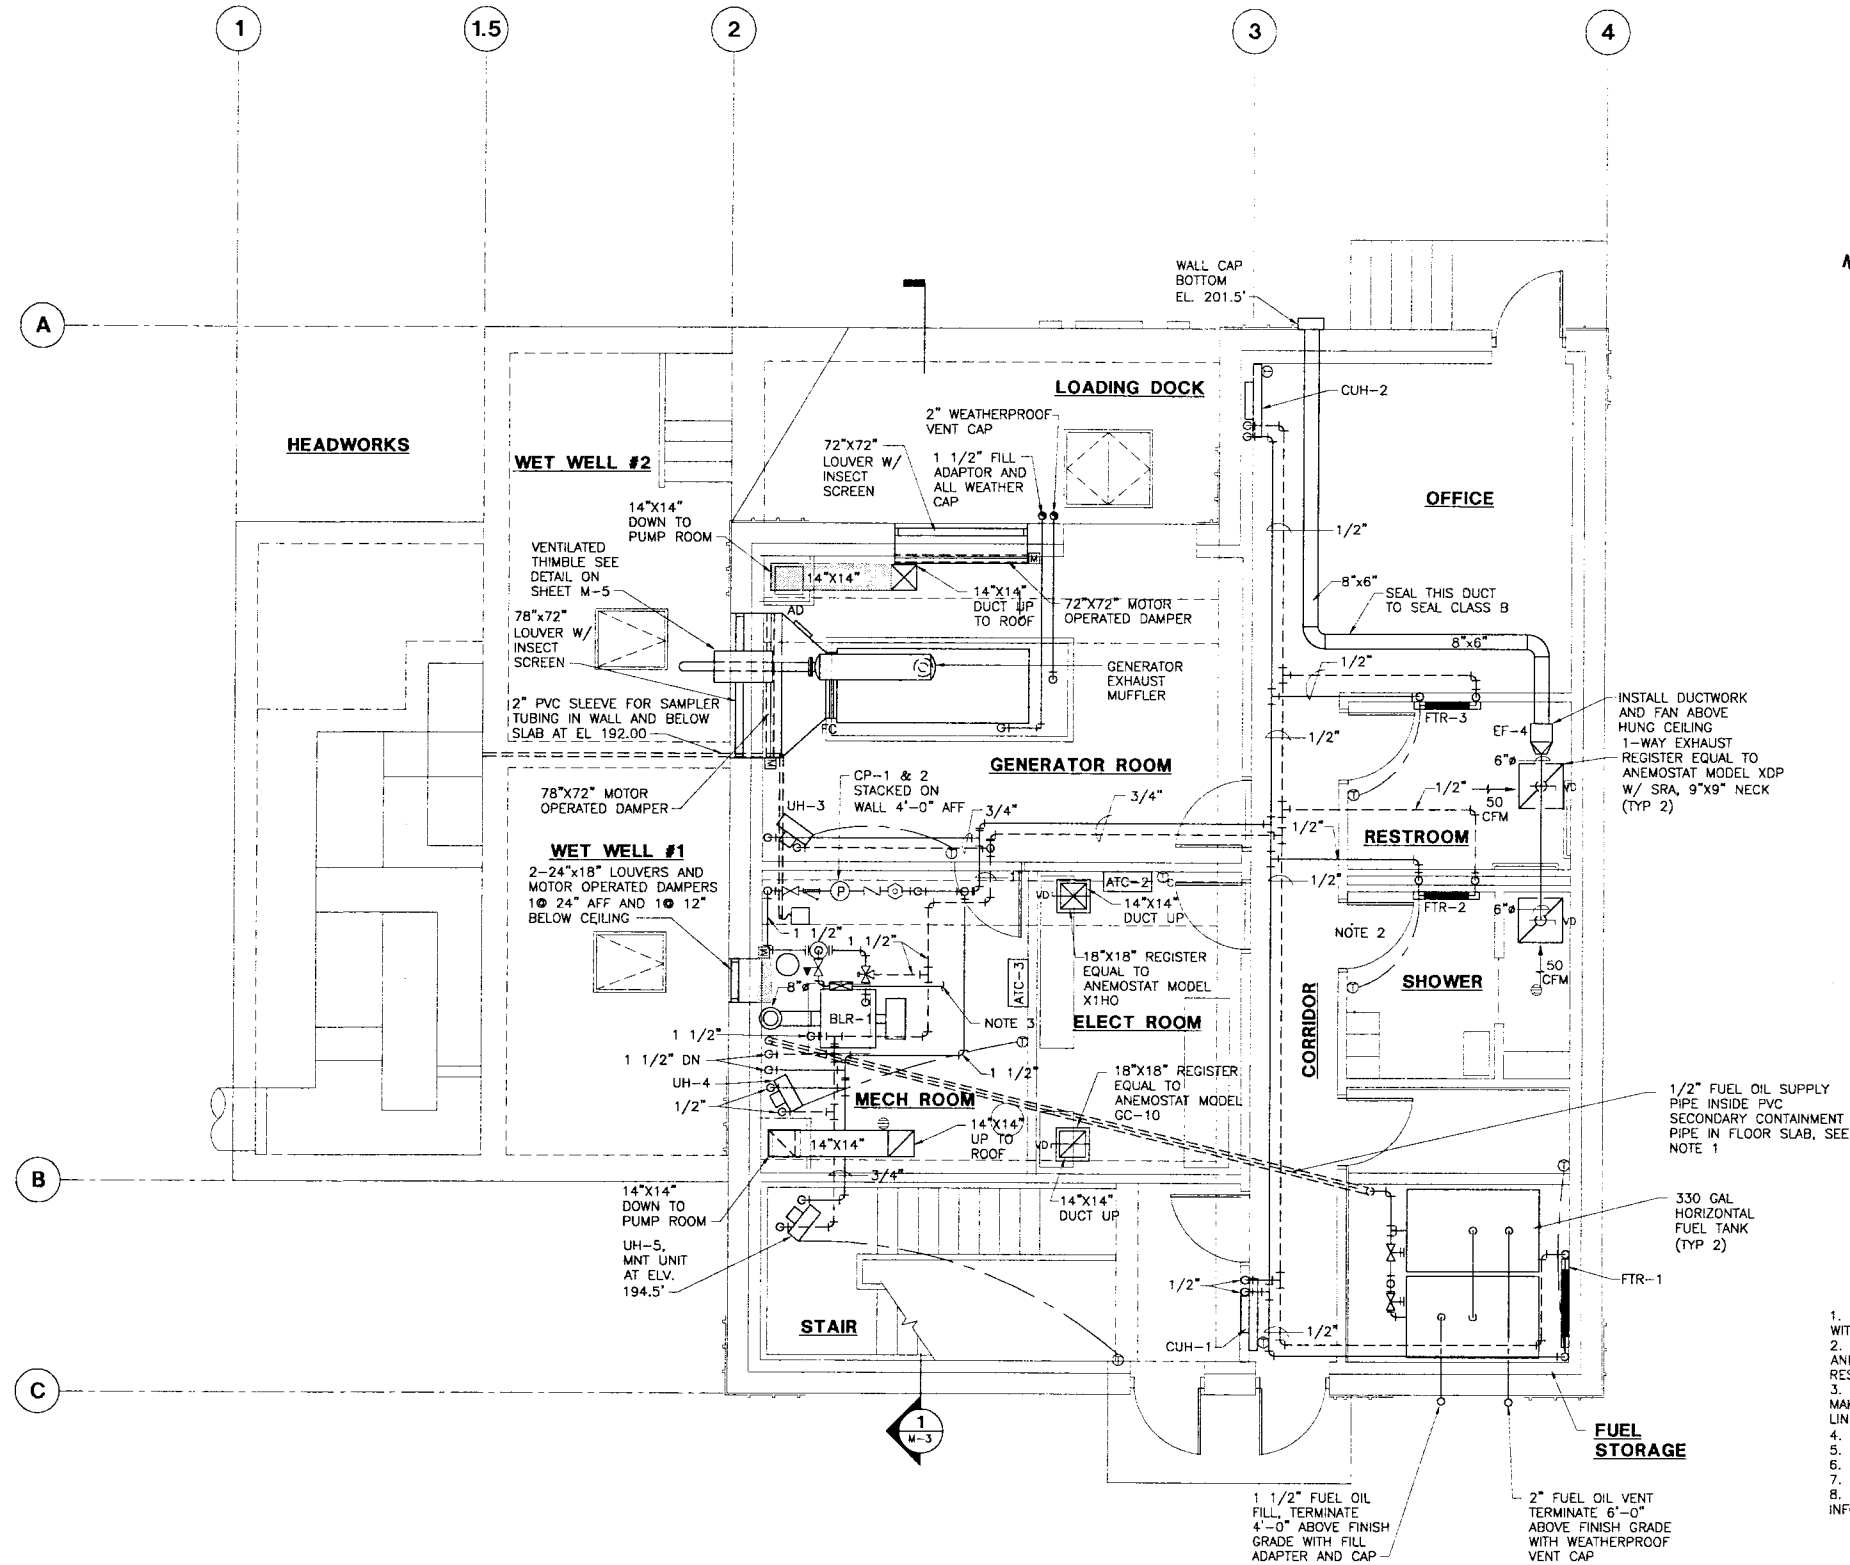

FIRST FLOOR PLAN
1/4"=1'-0"

CONSTRUCTION NOTES

1. COPPER FUEL PIPE WITHIN CONTAINMENT PIPE SHALL BE CONTINUOUS WITHOUT JOINTS.
2. INSTALL HWS & HWR PIPING INTERFERENCE FREE ABOVE HUNG CEILING AND BELOW BUILDING BATT INSULATION IN THE OFFICE, CORRIDOR, RESTROOM, AND SHOWER.
3. THIS IS THE EXTENT OF THE MECHANICAL SUBBIDDERS WORK INCLUDING MAKING AND TESTING THE FINAL CONNECTION TO THE BOILER WATER MAKEUP LINE PROVIDED BY THE PLUMBING SUBBIDDER.
4. REFER TO DWG M-5 FOR BOILER/HEATING PIPING DIAGRAM.
5. REFER TO DWG M-5 FOR RADIATION PIPING DIAGRAM.
6. REFER TO DWG M-5 FOR UNIT HEATER PIPING DIAGRAM.
7. REFER TO DWG M-2 FOR THE LOCATION OF EF-3, EF-5, SF-1 & SF-2.
8. REFER TO THE PLUMBING DRAWINGS FOR ADDITIONAL PLUMBING INFORMATION.

THESE RECORD DRAWINGS HAVE BEEN PREPARED IN PART ON THE BASIS OF THE INFORMATION FURNISHED BY THE TOWN OF EAST LONGMEADOW, MA. THE ENGINEER WILL NOT BE RESPONSIBLE FOR ANY ERRORS OR OMISSIONS WHICH HAVE BEEN INCORPORATED INTO THIS DOCUMENT AS A RESULT.

DEPARTMENT OF PUBLIC WORKS
TOWN OF EAST LONGMEADOW, MA
VINELAND AVENUE PUMP STATION
CONTRACTS NO. 1 AND NO. 2

FIRST FLOOR PLAN
DWG M-1
34 OF 49

Wright-Pierce
169 Main Street 700 Plaza Middlesex
Middletown, Connecticut USA 06457
TEL (860) 343-8297 FAX (860) 343-9504

NO.	REVISIONS	DATE	BY	DATE	PROJECT NO.	SCALE
1	RECORD DRAWINGS	12/04	WJM	12-02	7051K	AS NOTED
2	ISSUED FOR REVIEW	12-02	WJM	12-02	7051K	AS NOTED
3	ISSUED FOR BIDDING	2-03	WJM	12-02	7051K	AS NOTED
4	LAST WORKED ON		WJM	12-02	7051K	AS NOTED
5	LAST WORKED ON		WJM	12-02	7051K	AS NOTED
6	LAST WORKED ON		WJM	12-02	7051K	AS NOTED
7	LAST WORKED ON		WJM	12-02	7051K	AS NOTED
8	LAST WORKED ON		WJM	12-02	7051K	AS NOTED
9	LAST WORKED ON		WJM	12-02	7051K	AS NOTED
10	LAST WORKED ON		WJM	12-02	7051K	AS NOTED
11	LAST WORKED ON		WJM	12-02	7051K	AS NOTED
12	LAST WORKED ON		WJM	12-02	7051K	AS NOTED
13	LAST WORKED ON		WJM	12-02	7051K	AS NOTED
14	LAST WORKED ON		WJM	12-02	7051K	AS NOTED
15	LAST WORKED ON		WJM	12-02	7051K	AS NOTED
16	LAST WORKED ON		WJM	12-02	7051K	AS NOTED
17	LAST WORKED ON		WJM	12-02	7051K	AS NOTED
18	LAST WORKED ON		WJM	12-02	7051K	AS NOTED
19	LAST WORKED ON		WJM	12-02	7051K	AS NOTED
20	LAST WORKED ON		WJM	12-02	7051K	AS NOTED