
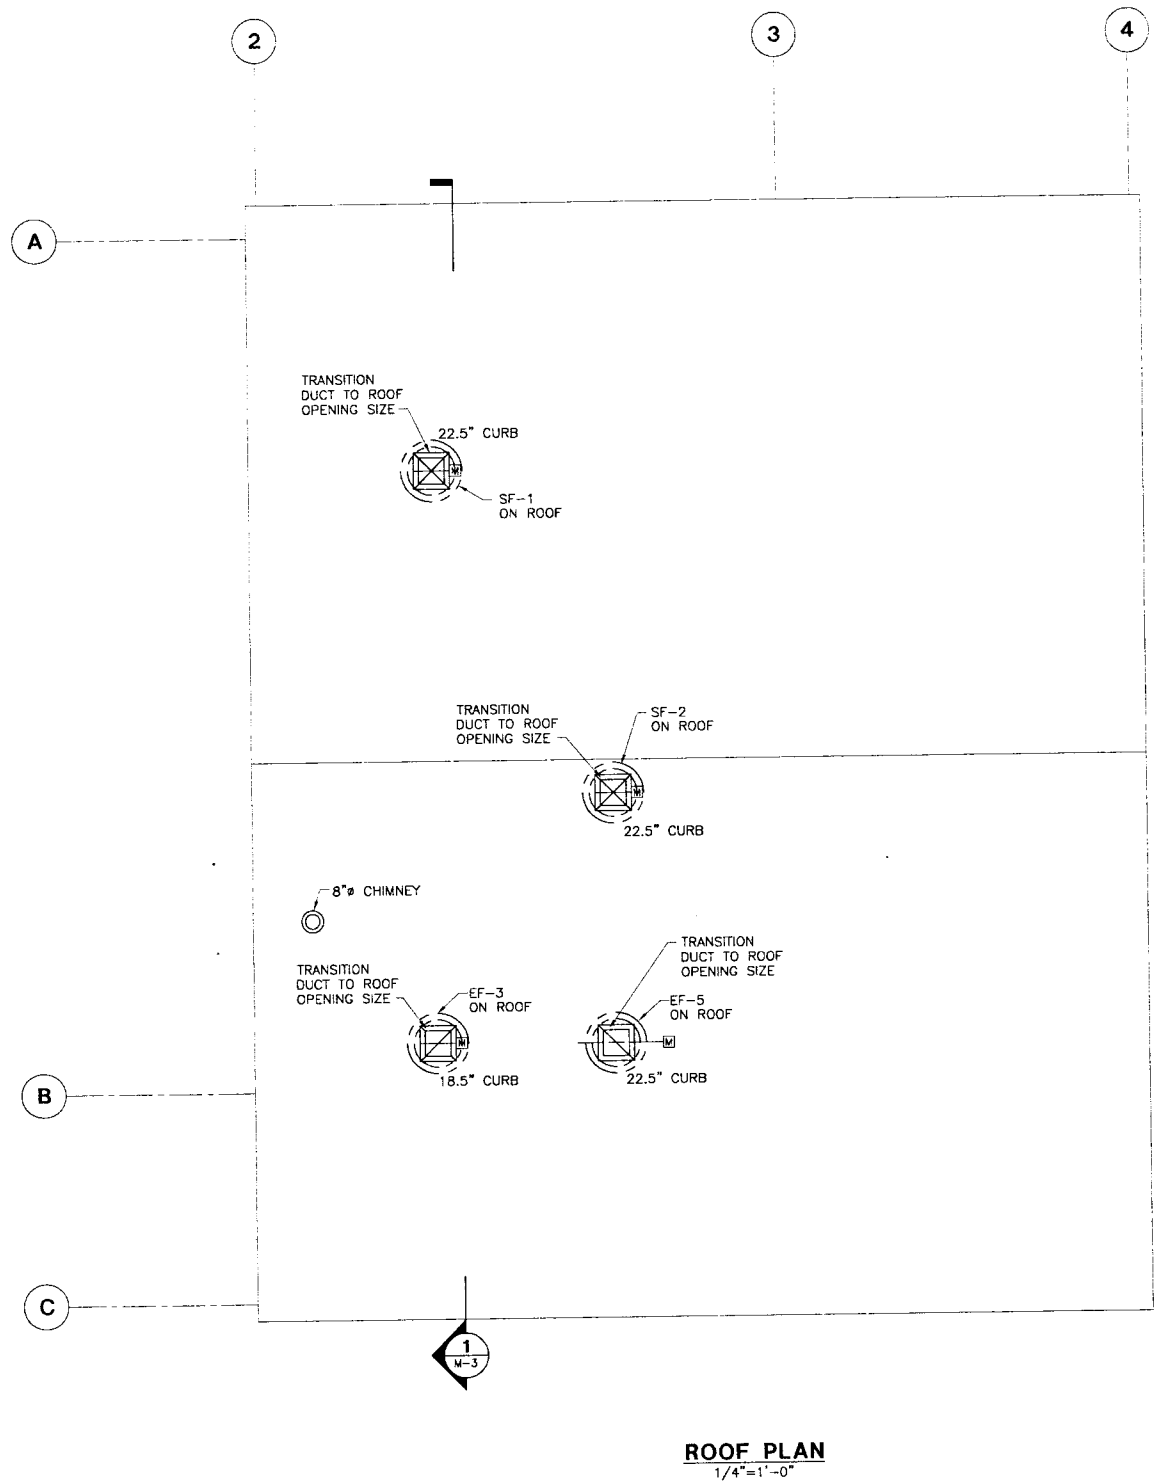


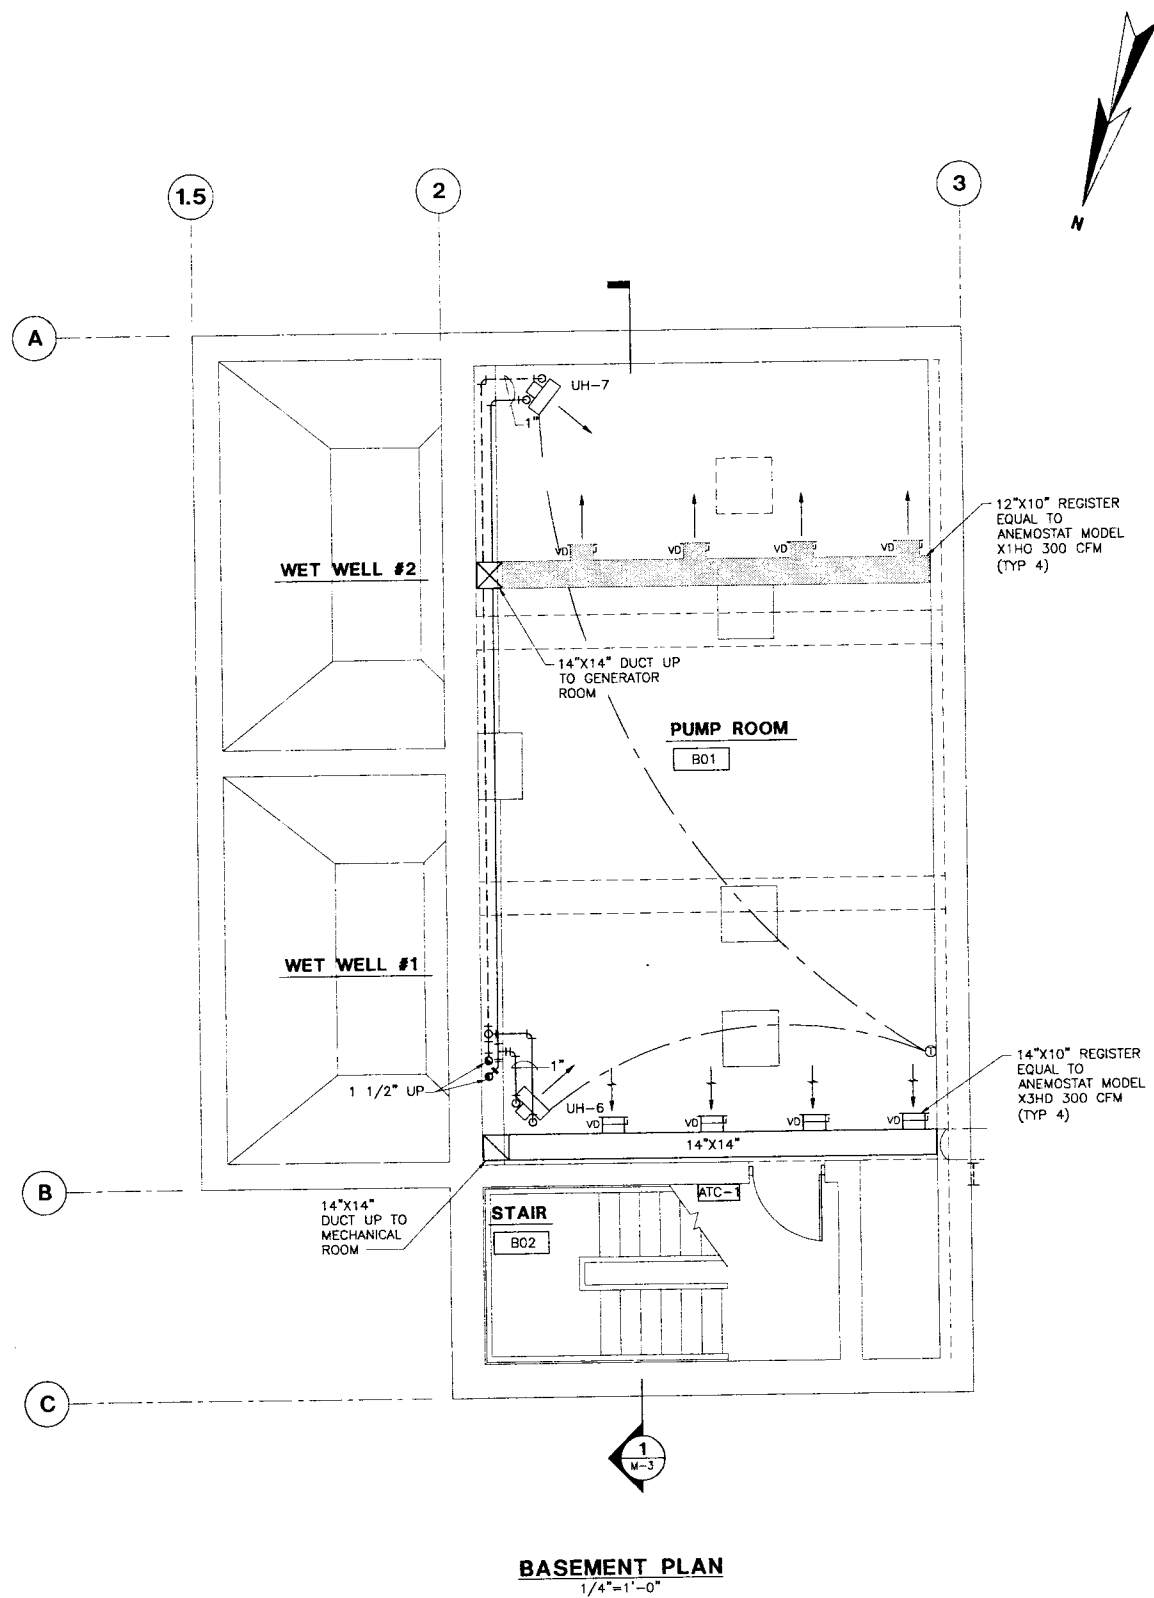

THESE RECORD DRAWINGS HAVE BEEN PREPARED IN PART ON THE BASIS OF THE INFORMATION FURNISHED BY THE TOWN OF EAST LONGMEADOW, MA. THE ENGINEER WILL NOT BE RESPONSIBLE FOR ANY ERRORS OR OMISSIONS WHICH HAVE BEEN INCORPORATED INTO THIS DOCUMENT AS A RESULT.

DEPARTMENT OF PUBLIC WORKS
TOWN OF EAST LONGMEADOW, MA
VINELAND AVENUE PUMP STATION
CONTRACTS NO. 1 AND NO. 2
BASEMENT AND ROOF PLANS

DWG M-2
35 OF 49

Wright-Pierce
169 Main Street 700 Plaza Middlesex
Middletown, Connecticut USA 06457
TEL (860) 343-8297 FAX (860) 343-9504

CHECKED BY SCH
DATE 12-19-02
APPROVED BY SCH
DATE 1-31-03
PROJECT NO. 7051K
SCALE AS NOTED

NO.	RECORD DRAWINGS	REVISIONS	DATE	BY
1	12/04			
2				
3				
4				

ISSUED FOR REVIEW	12-02
ISSUED FOR BIDDING	2-03
DATE FOR CONSTRUCTION	
DATE FOR WORK ON	
DATE FOR	