


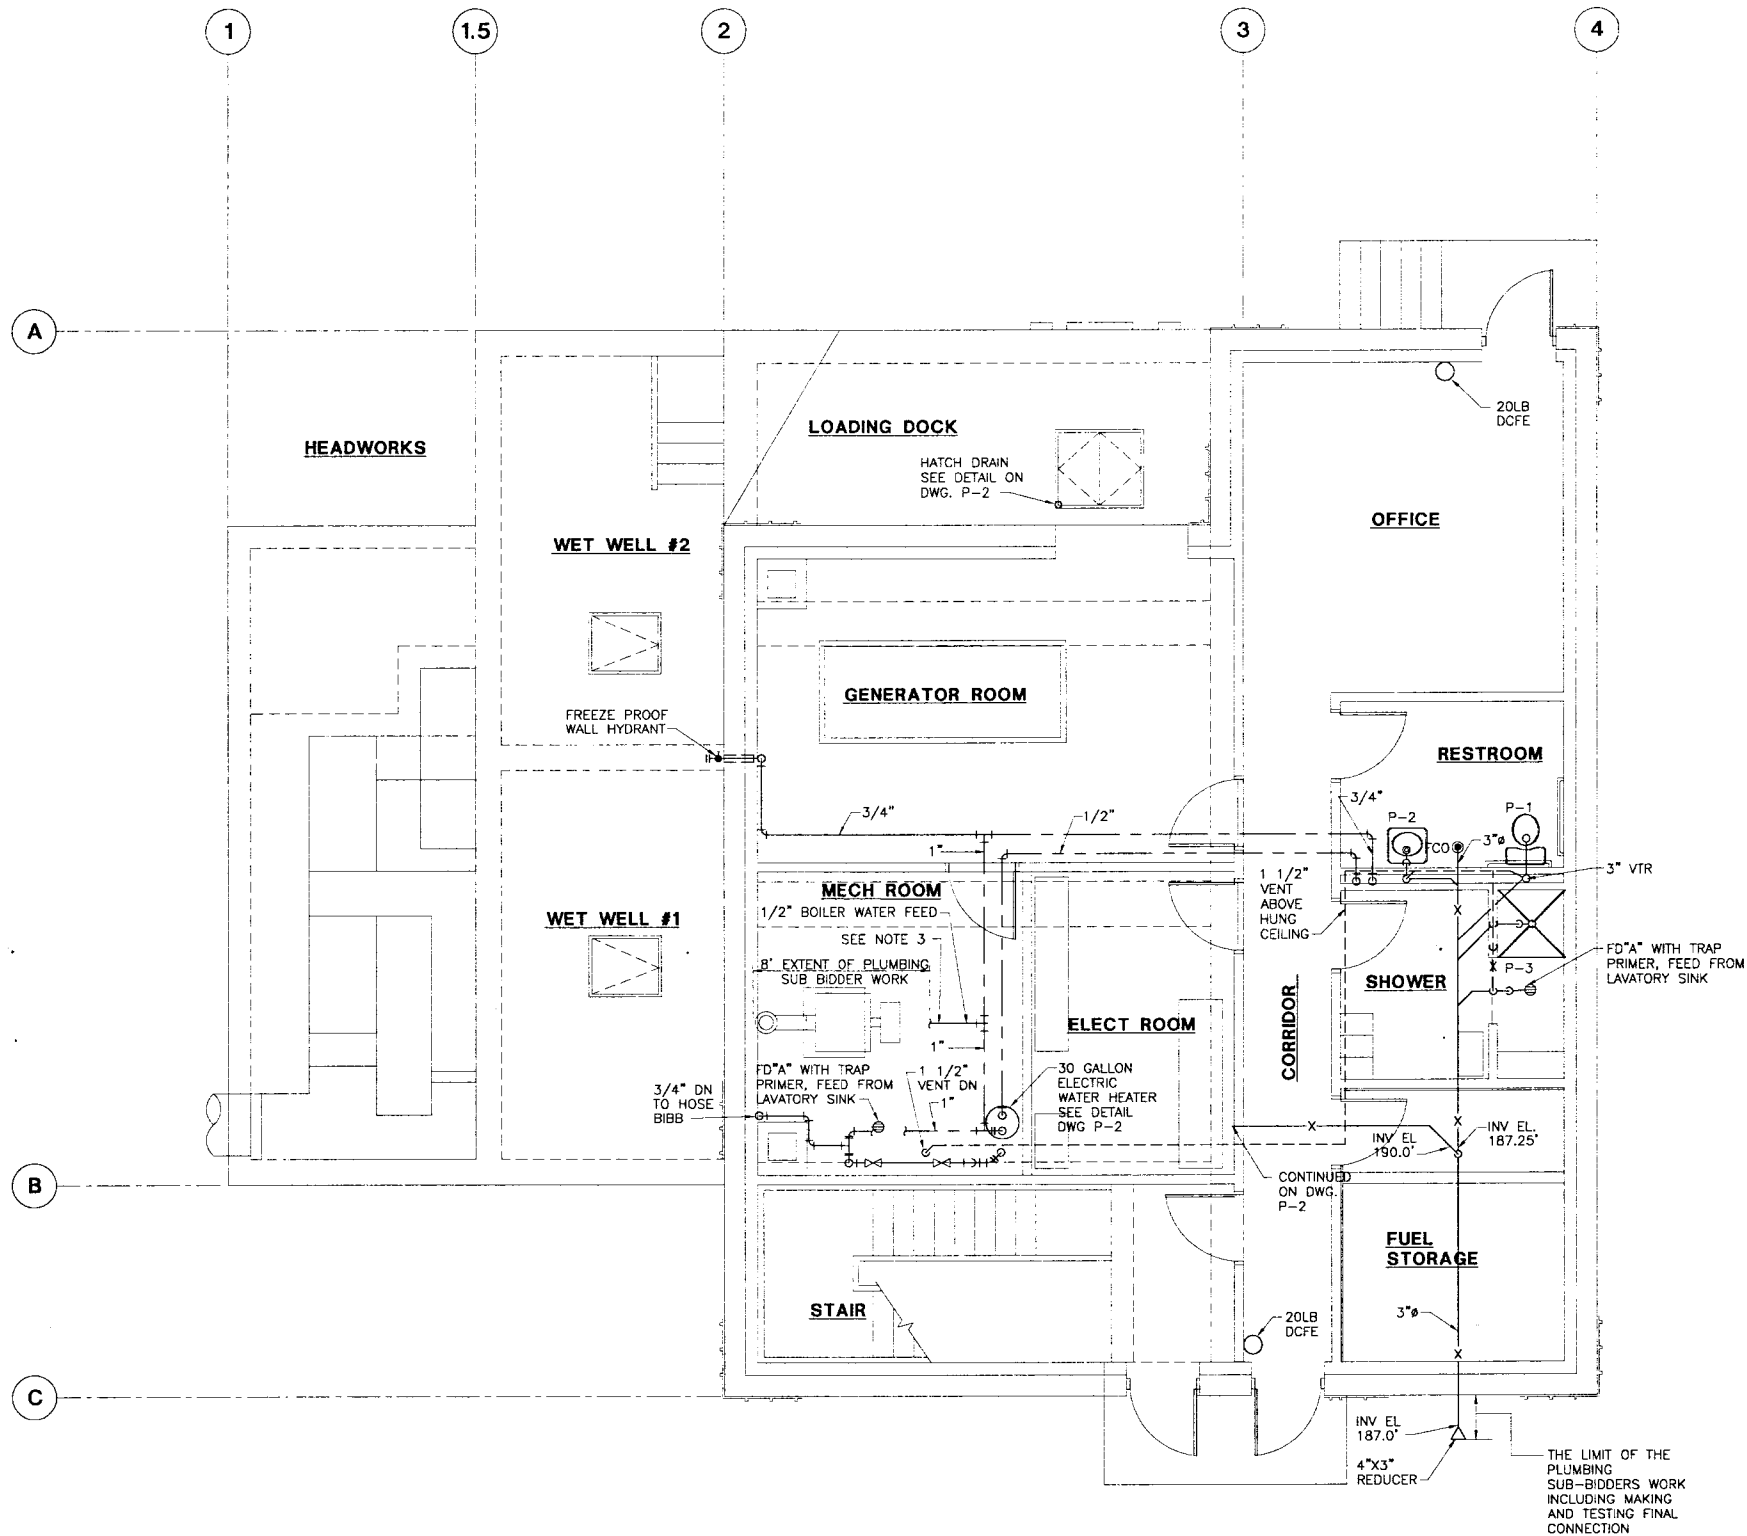

CONSTRUCTION NOTES

1. THE PLUMBING SUB-CONTRACTOR IS TO COORDINATE THE LAYOUT OF THE PLUMBING WITH THE MECHANICAL, GENERAL CONTRACTOR AND ELECTRICAL SUB-CONTRACTOR.
2. REFER TO DRAWING P-2 FOR INFORMATION ON THE PLUMBING FIXTURES.
3. REFER TO THE MECHANICAL DRAWINGS FOR ADDITIONAL PLUMBING INFORMATION

FIRST FLOOR PLAN

1/4"=1'-0"

THESE RECORD DRAWINGS HAVE BEEN PREPARED, IN PART, ON THE BASIS OF THE INFORMATION PROVIDED BY THE TOWN OF EAST LONGMEADOW, MA. THE CONTRACTOR SHALL BE RESPONSIBLE FOR ANY ERRORS OR OMISSIONS WHICH HAVE BEEN INCORPORATED INTO THIS DOCUMENT AS A RESULT.

DEPARTMENT OF PUBLIC WORKS
TOWN OF EAST LONGMEADOW, MA
VINELAND AVENUE PUMP STATION
CONTRACTS NO. 1 AND NO. 2

DWG P-1

Wright-Pierce
169 Main Street 700 Plaza Middlesex
Middletown, Connecticut USA 06457
TEL (860) 343-8297 FAX (860) 343-9504

DOWN BY JML
CHECKED BY SCH
DATE 12-19-02
APPROVED BY SCH
DATE 12-31-02
BOOK NO.
PROJECT NO. 7051K
SCALE AS NOTED

NO. 1

RECORD DRAWINGS 12/04

REVISED

DATE

ISSUED FOR REVIEW 12-02

ISSUED FOR BIDDING 2-03

DATE LOCATED

DATE WORKED ON

DATE