

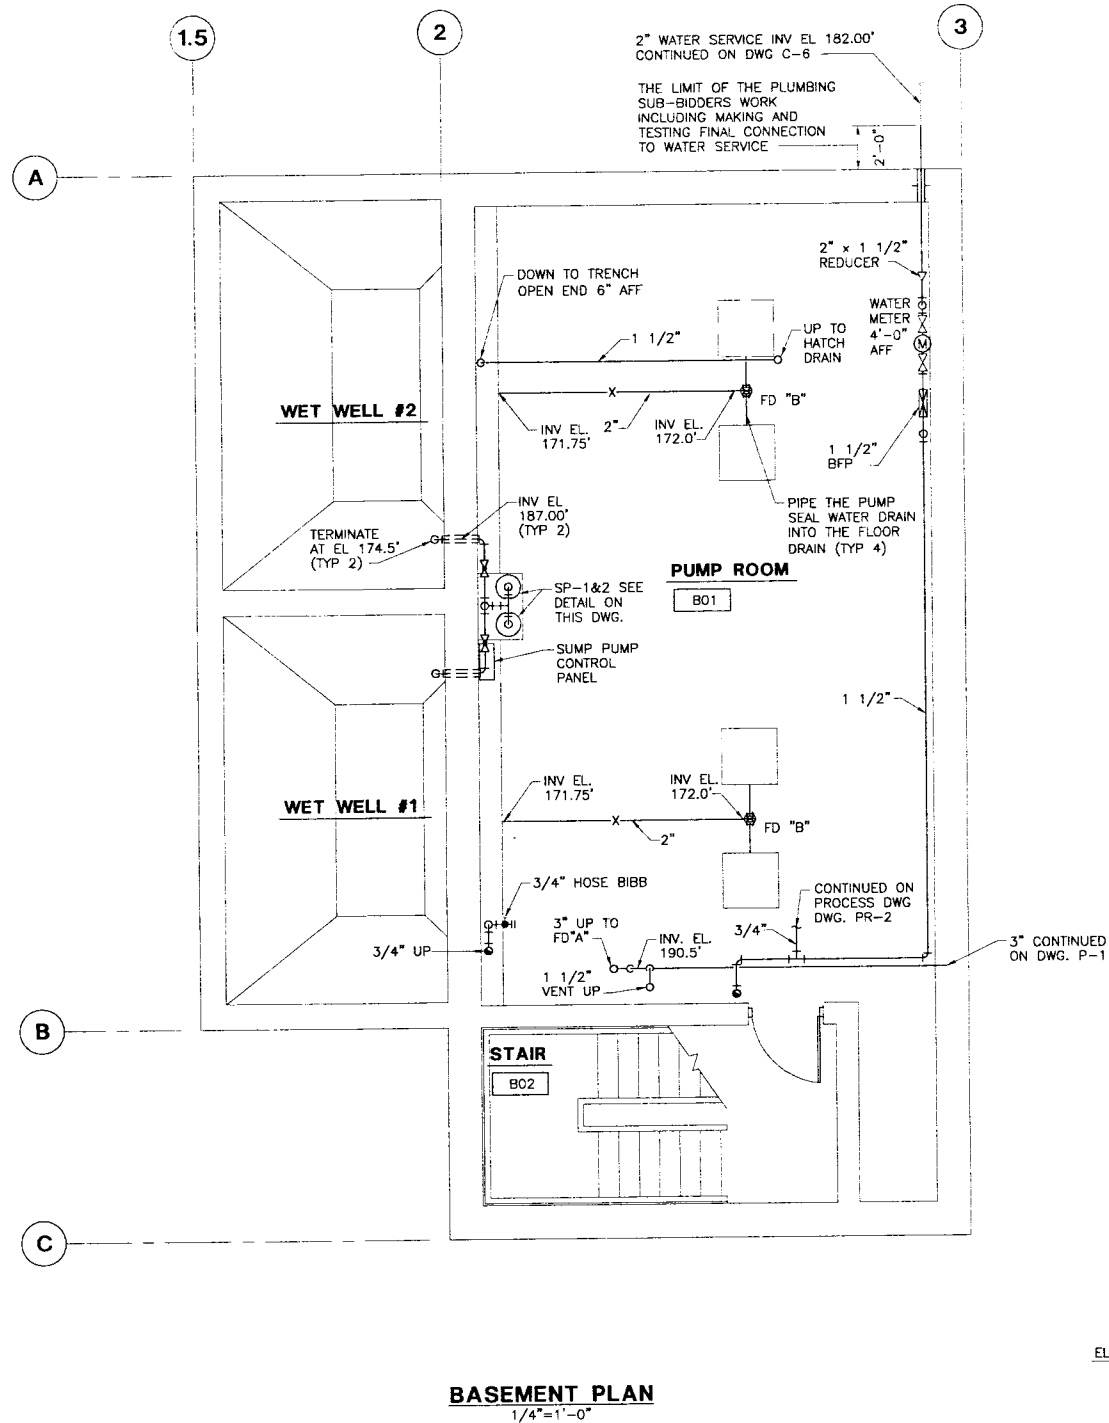
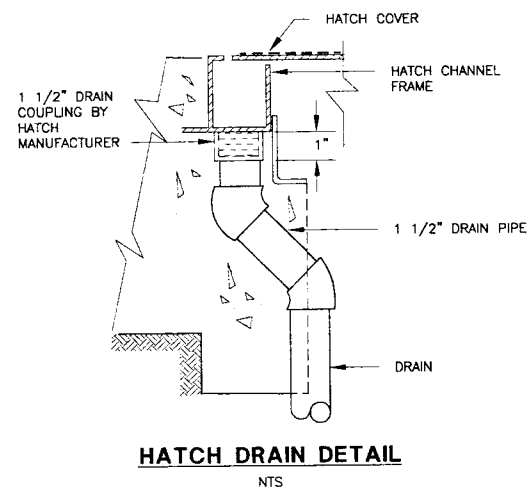


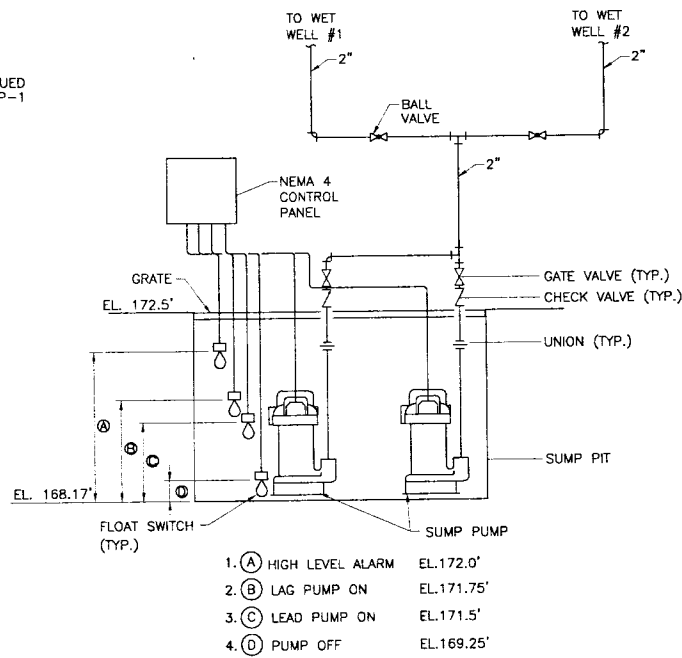


BACKFLOW PREVENTER SCHEDULE					
SIZE	LOCATION	TYPE	SERVICE	DESIGN FLOW	MAXIMUM PRESSURE DROP
1 1/2"	PUMP ROOM WATER METER	REDUCED PRESSURE ZONE	POTABLE WATER	30	8

PLUMBING FIXTURE SCHEDULE							
P NUMBER	TYPE OF FIXTURE	FIXTURE UNITS		DRAINAGE		WATER	
		DRAIN	CW/HW	WP	VP	CW	HW
P-1	WATER CLOSET	4	3	3"	1 1/2"	3/8"	---
P-2	LAVATORY	1	1	1 1/4"	1 1/4"	3/8"	3/8"
P-3	SHOWER	2	2	2"	1 1/4"	1/2"	1/2"

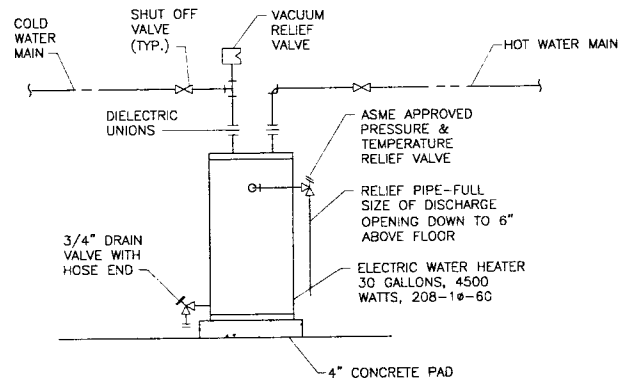

PLUMBING LEGEND

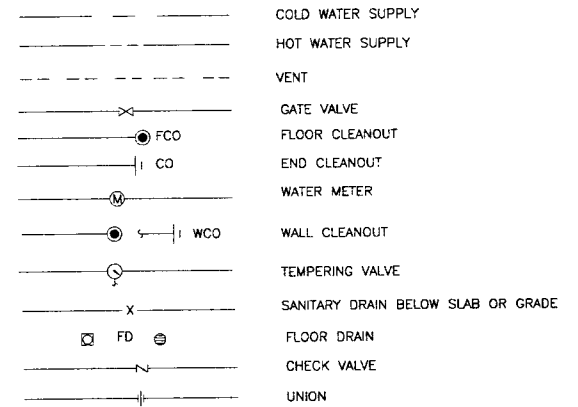

ABBREVIATIONS

DCFE	DRY CHEMICAL FIRE EXTINGUISHER
ELEV	ELEVATION
FF EL	FINISH FLOOR ELEVATION
FPWH	FROST PROOF WALL HYDRANT
GPM	GALLONS PER MINUTE
HB	HOSE BIBB
INV EL	INVERT ELEVATION
TYP	TYPICAL
VTR	VENT THRU ROOF
W/	WITH

THESE RECORD DRAWINGS HAVE BEEN PREPARED, IN PART, ON THE BASIS OF THE INFORMATION FURNISHED BY OTHERS. THE ENGINEER WILL NOT BE RESPONSIBLE FOR ANY ERRORS OR OMISSIONS WHICH HAVE BEEN INCORPORATED INTO THIS DOCUMENT AS A RESULT.

DEPARTMENT OF PUBLIC WORKS
TOWN OF EAST LONGMEADOW, MA
VINELAND AVENUE PUMP STATION
CONTRACTS NO. 1 AND NO. 2
BASEMENT PLAN, DETAILS
AND LEGEND

DWG P-2

40 OF 49

Wright-Pierce
169 Main Street 700 Plaza Middlesex
Middletown, Connecticut USA 06457
TEL (860) 343-8297 FAX (860) 343-9504

PROJECT NO.	7051K
SCALE	AS NOTED
DRAWN BY	AWL
CHECKED BY	SCH
DATE	12-18-02
APPROVED BY	SCH
DATE	1-31-03
BOOK NO.	
PROJECT NO.	7051K
SCALE	AS NOTED
RECORD DRAWINGS	12/04
REVISIONS	
DATE	
BY	
DESCRIPTION	
12-02	ISSUED FOR REVIEW
2-03	ISSUED FOR BIDDING
	WALL TOOKS
	LAST WARD ON
	DATE
	NAME